


ATTIC MECHANICAL PART PLAN
SCALE: 1/8"=1'-0"

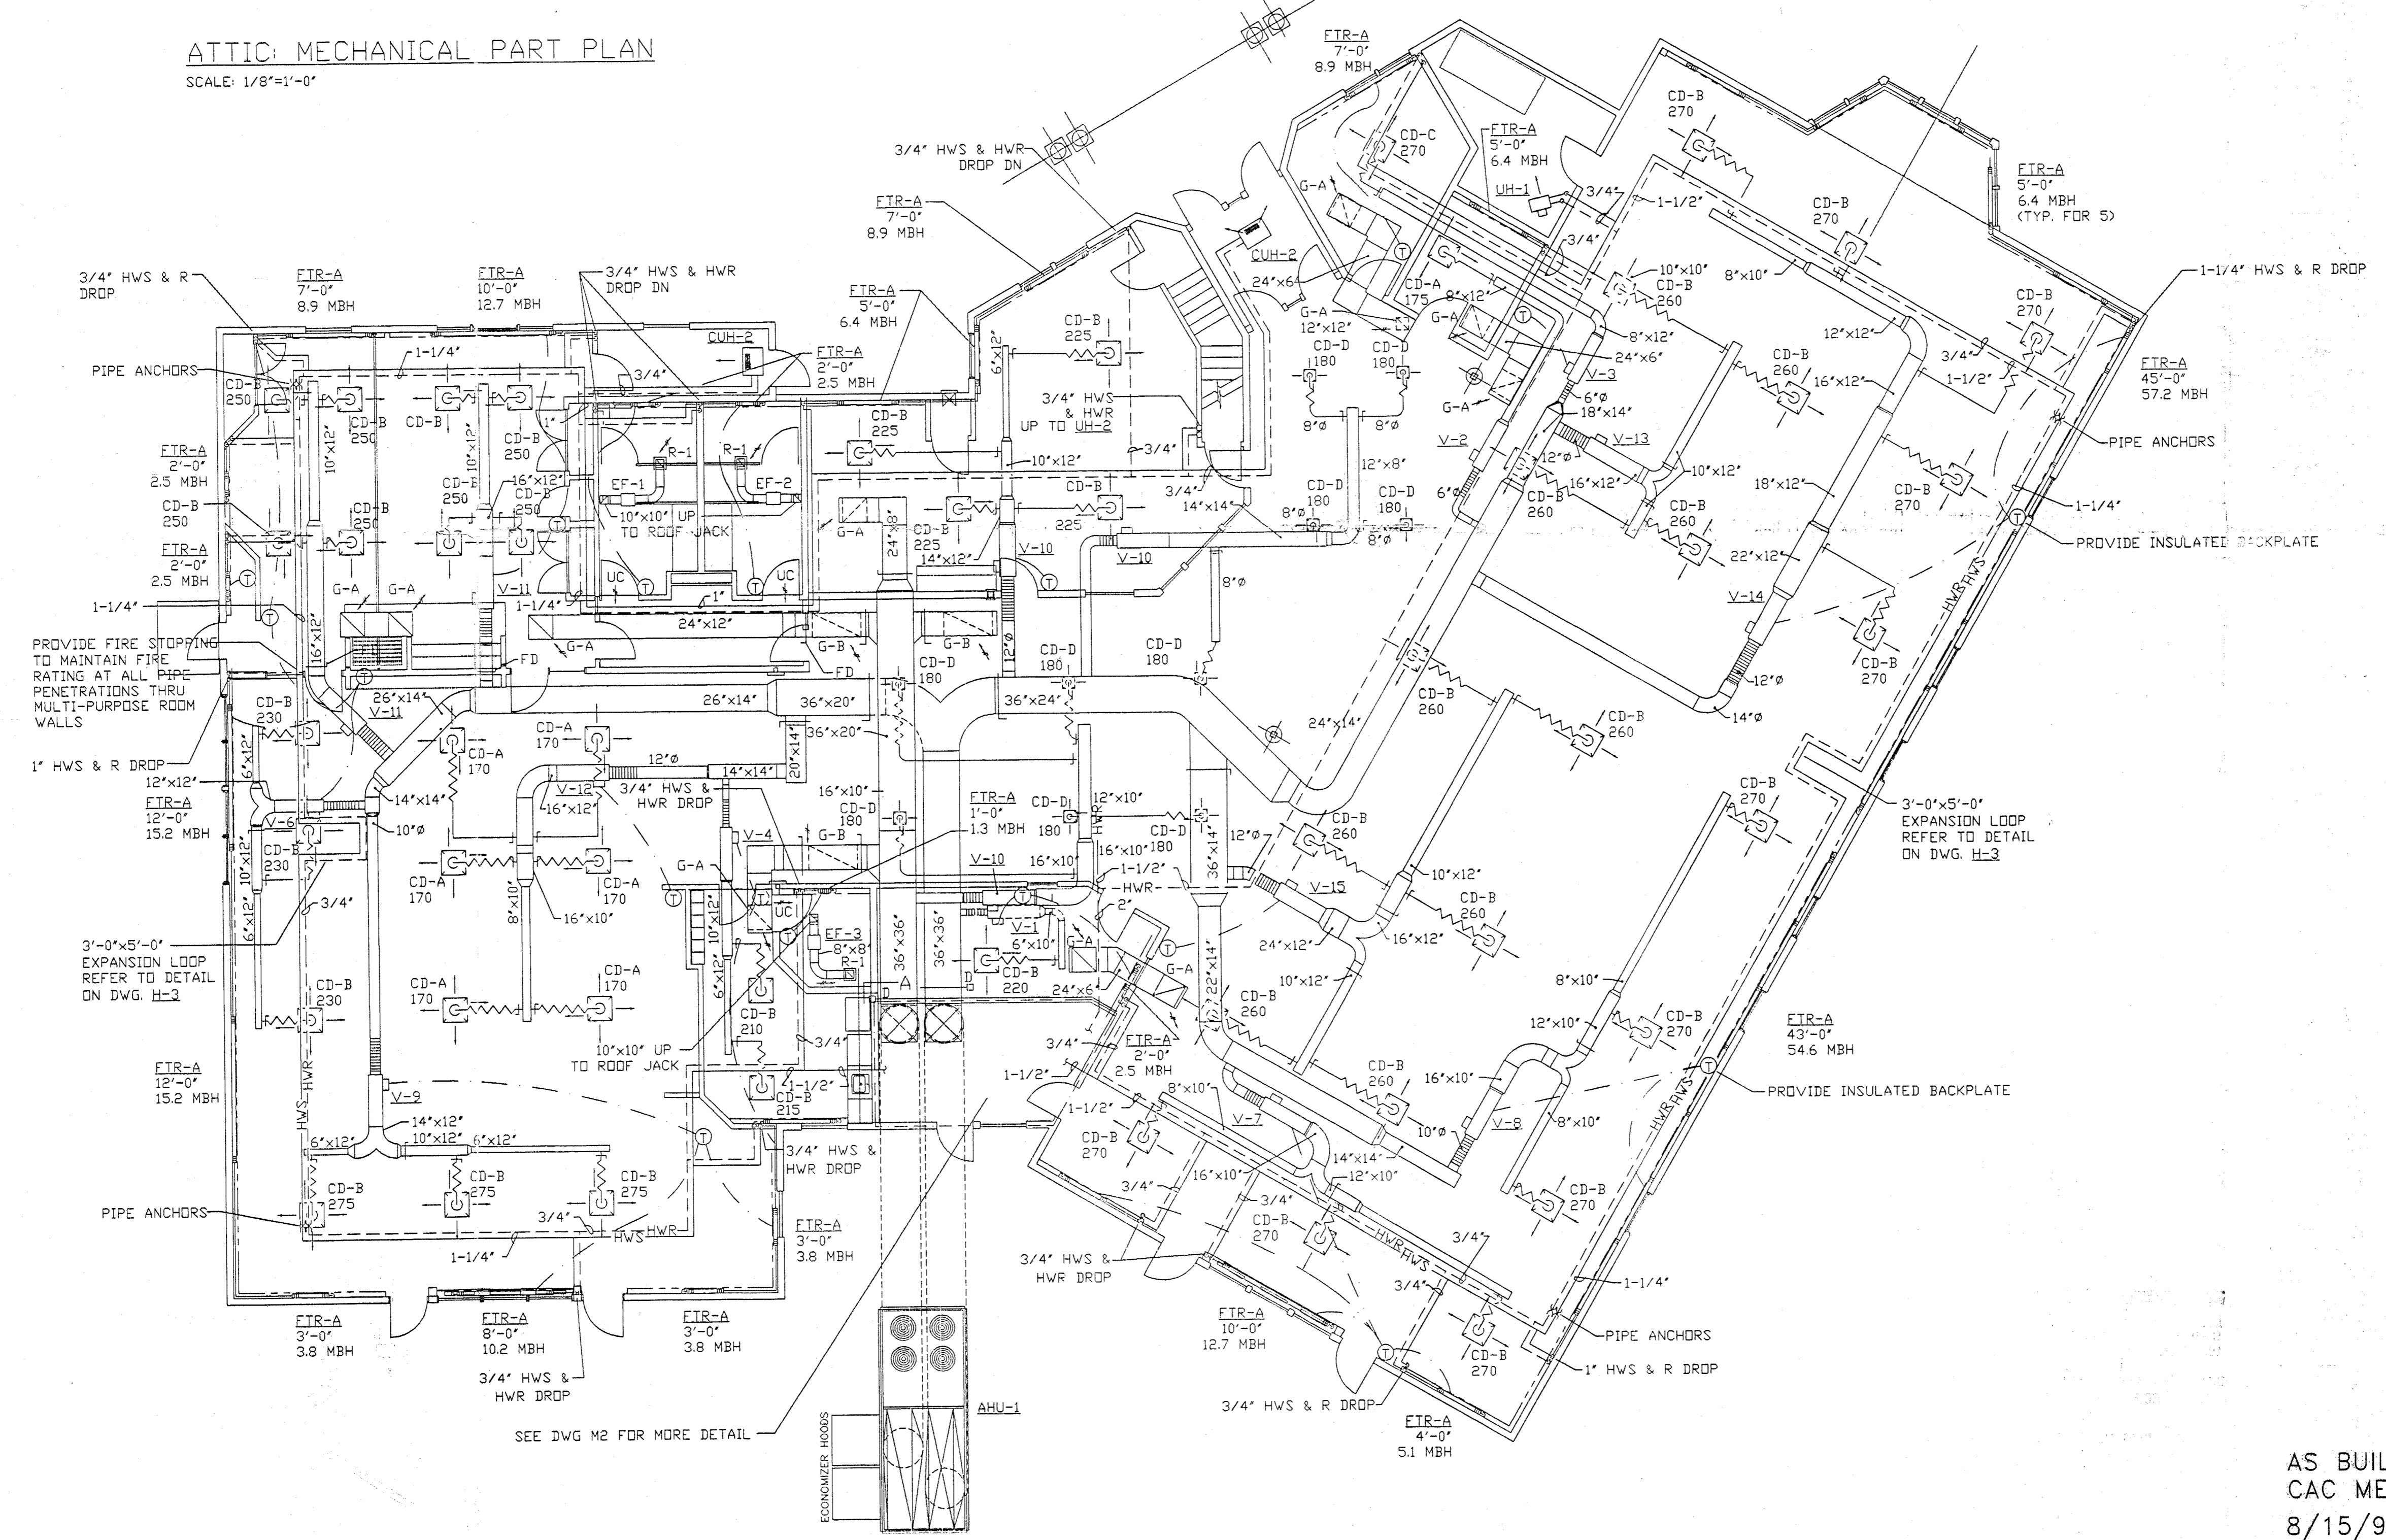

MECHANICAL FLOOR PLAN
SCALE: 1/8"=1'-0"

CAC MECHANICAL SERVICES, INC.
68 STILES ROAD
SALEM N.H. 03079
TEL (603) 893-6618 FAX (603) 893-0314
HEATING - AIR CONDITIONING - PLUMBING - CONTROLS

HVAC
DATE: AUGUST 15, 1997
SCALE: 1/8" = 1'-0"

NESMITH LIBRARY
3 NORTH LOWELL RD
WINDHAM, NH 03087

REVISIONS:

DRG. NO.
M1

AS BUILT DRAWINGS
CAC MECHANICAL SERVICES, INC.
8/15/97 DATE *R. O. Clare* BY